



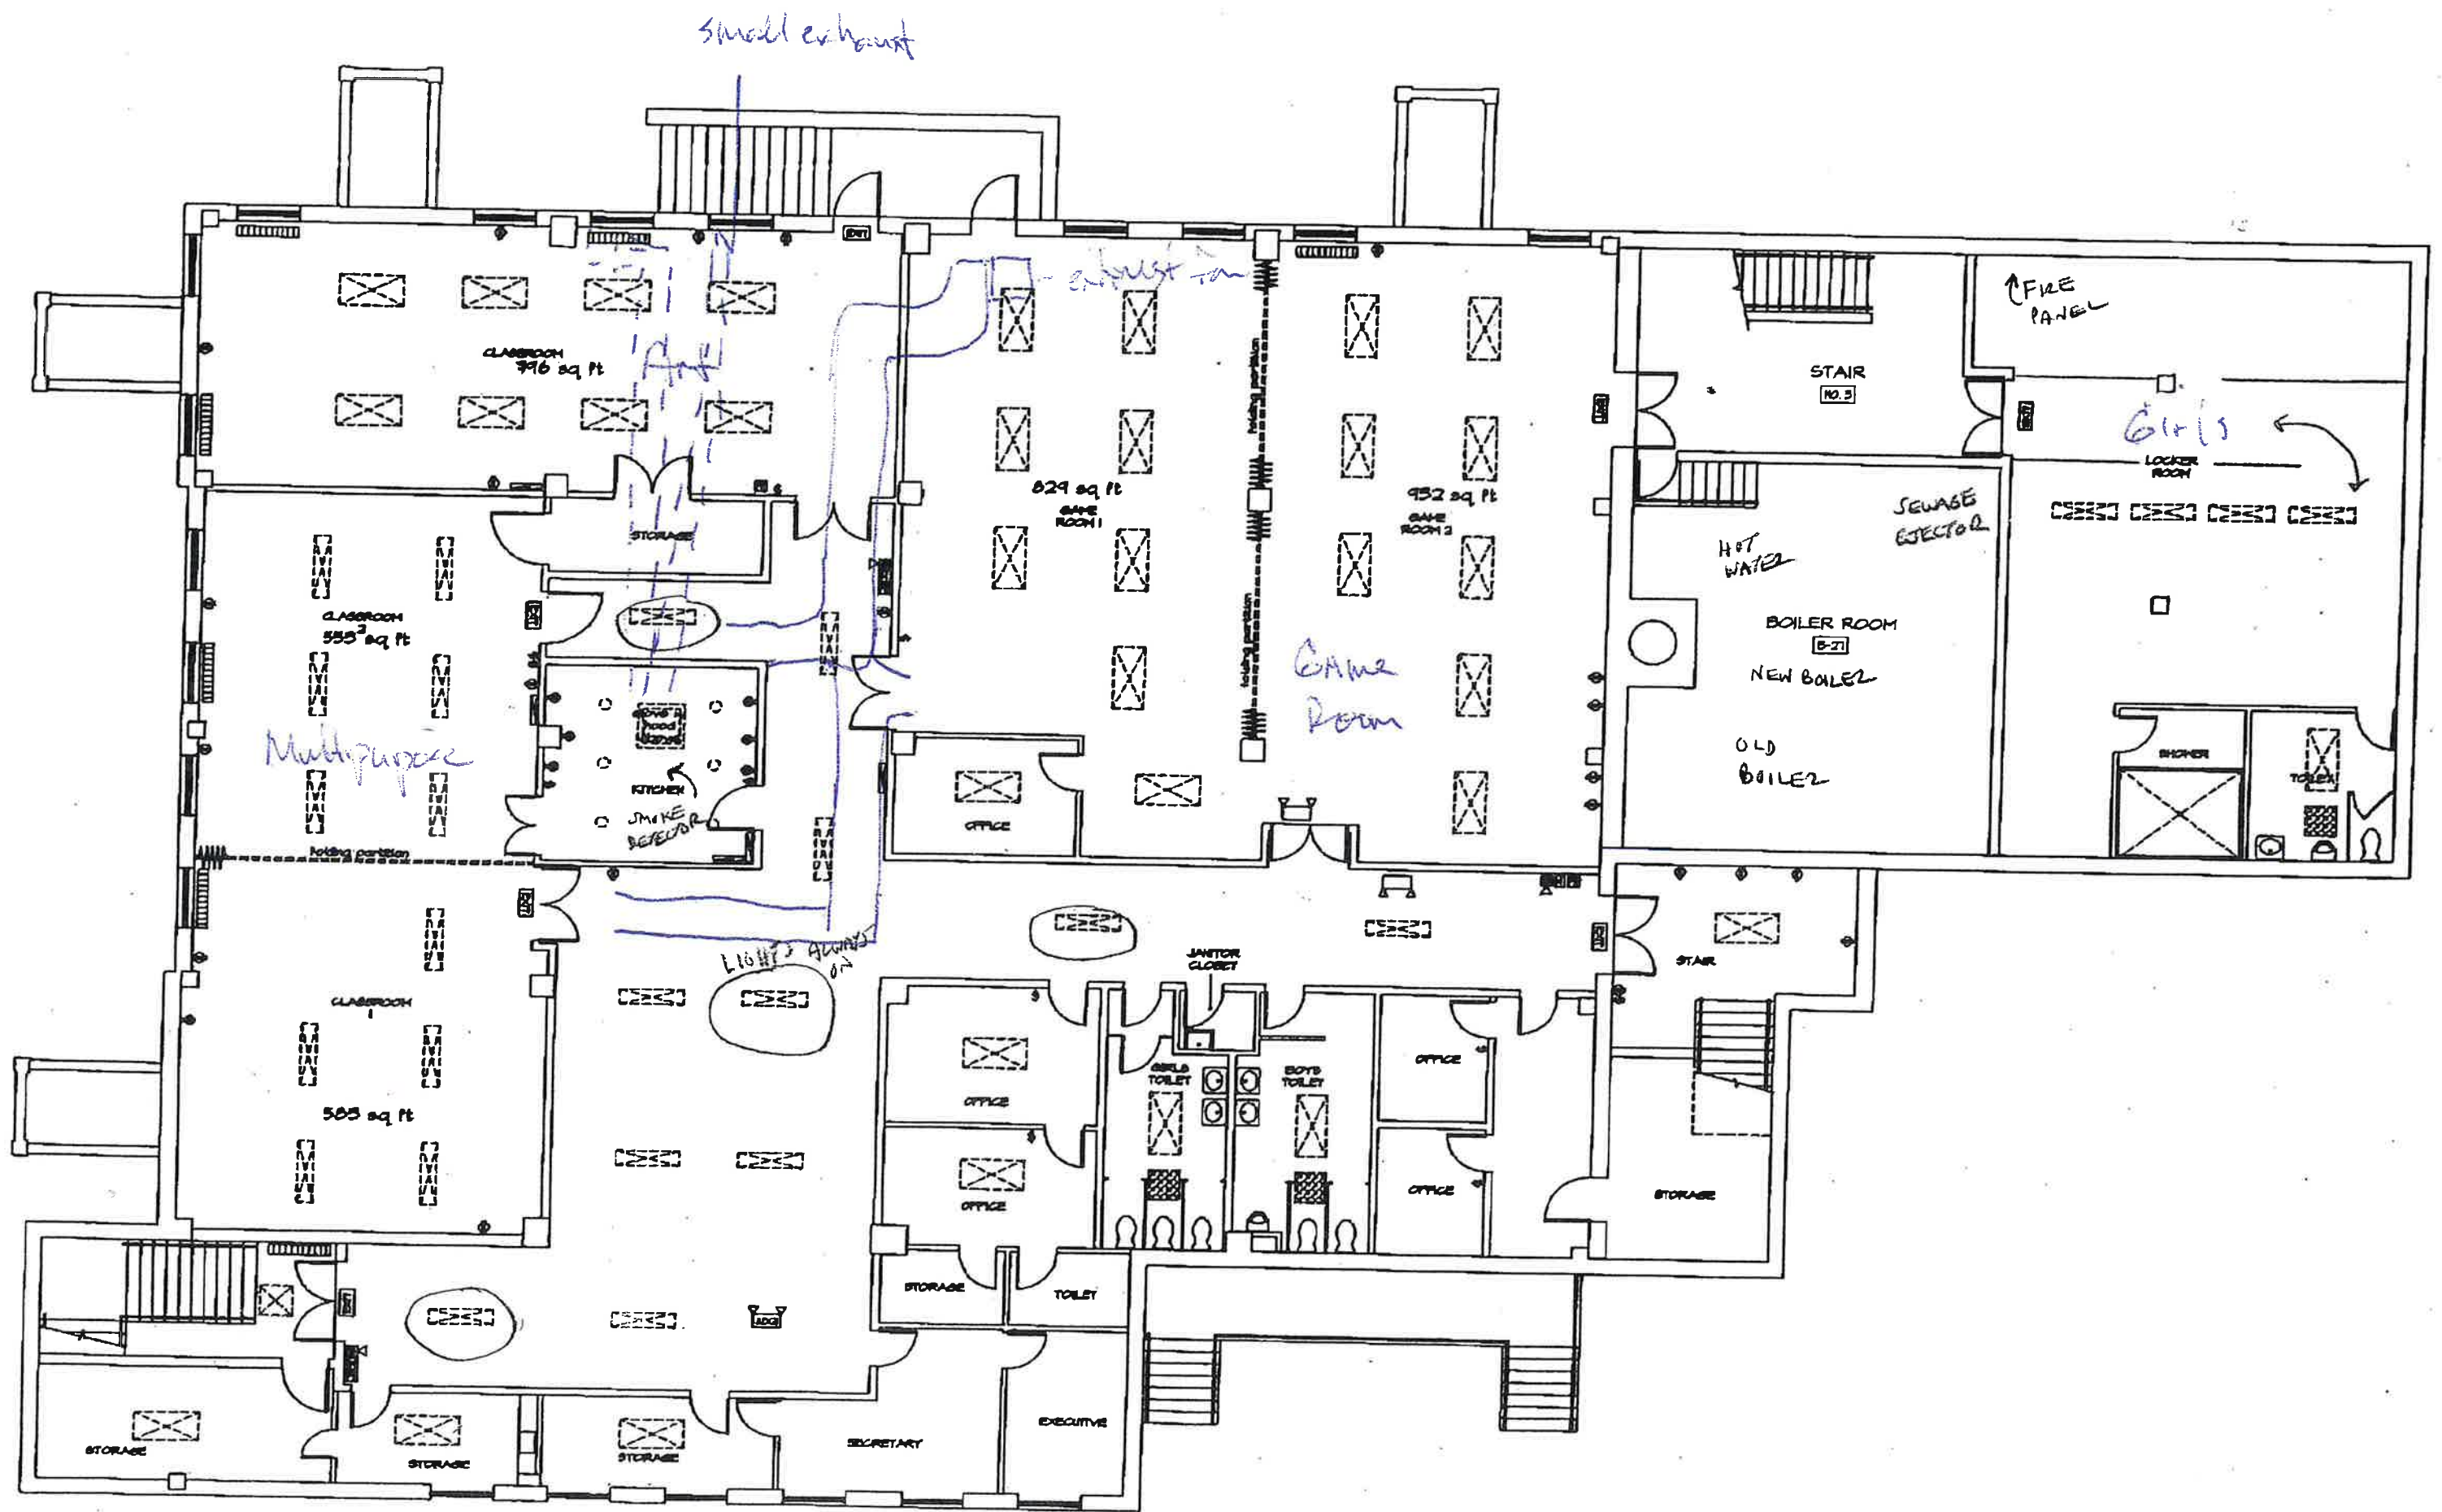

JELLEF'S BOY'S & GIRL'S CLUB-BASEMENT FLOOR

PANIC BARS ON CIRCLED DOORS

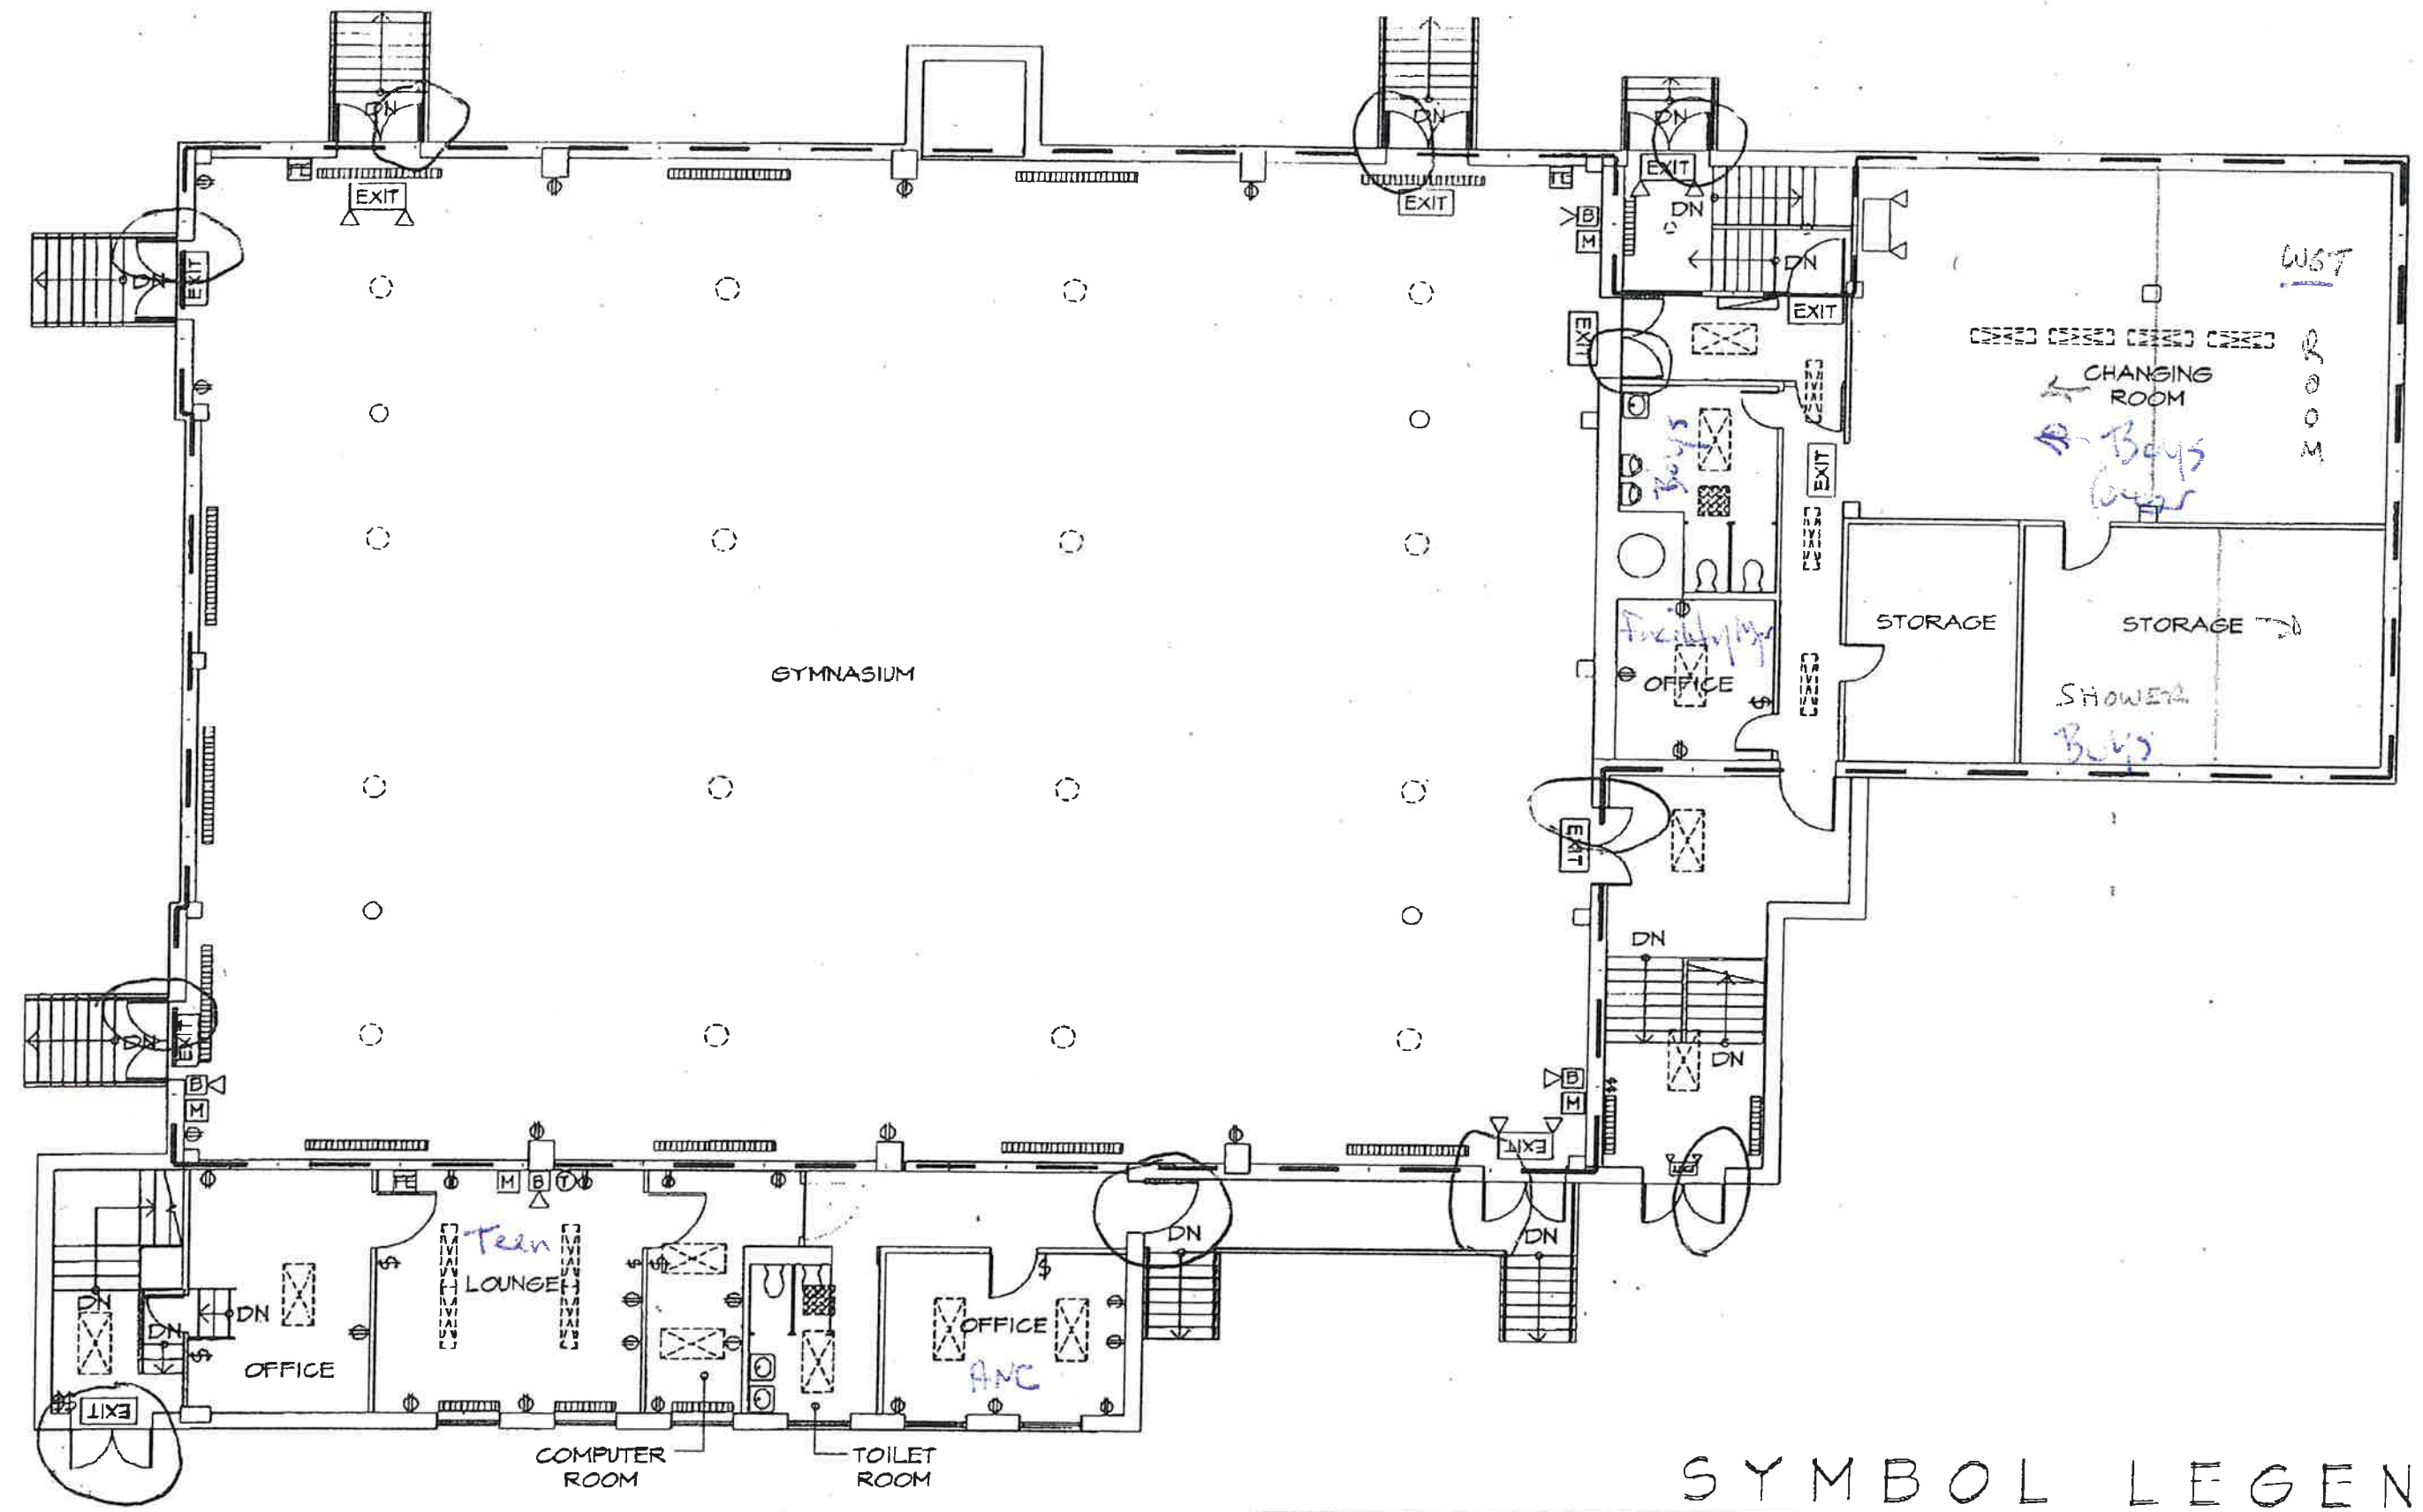

1 UPPER LEVEL FLOOR PLAN
scale: 1/8" = 1'-0"

SYMBOL LEGEND

PANELS		FIRE ALARM EQUIPMENT	
	FIRE PANEL		SMOKE DETEC
	CIRCUIT BREAKER PANEL/FUSE PANEL		FIRE EXTINGUI